


UTILITIES PLAN

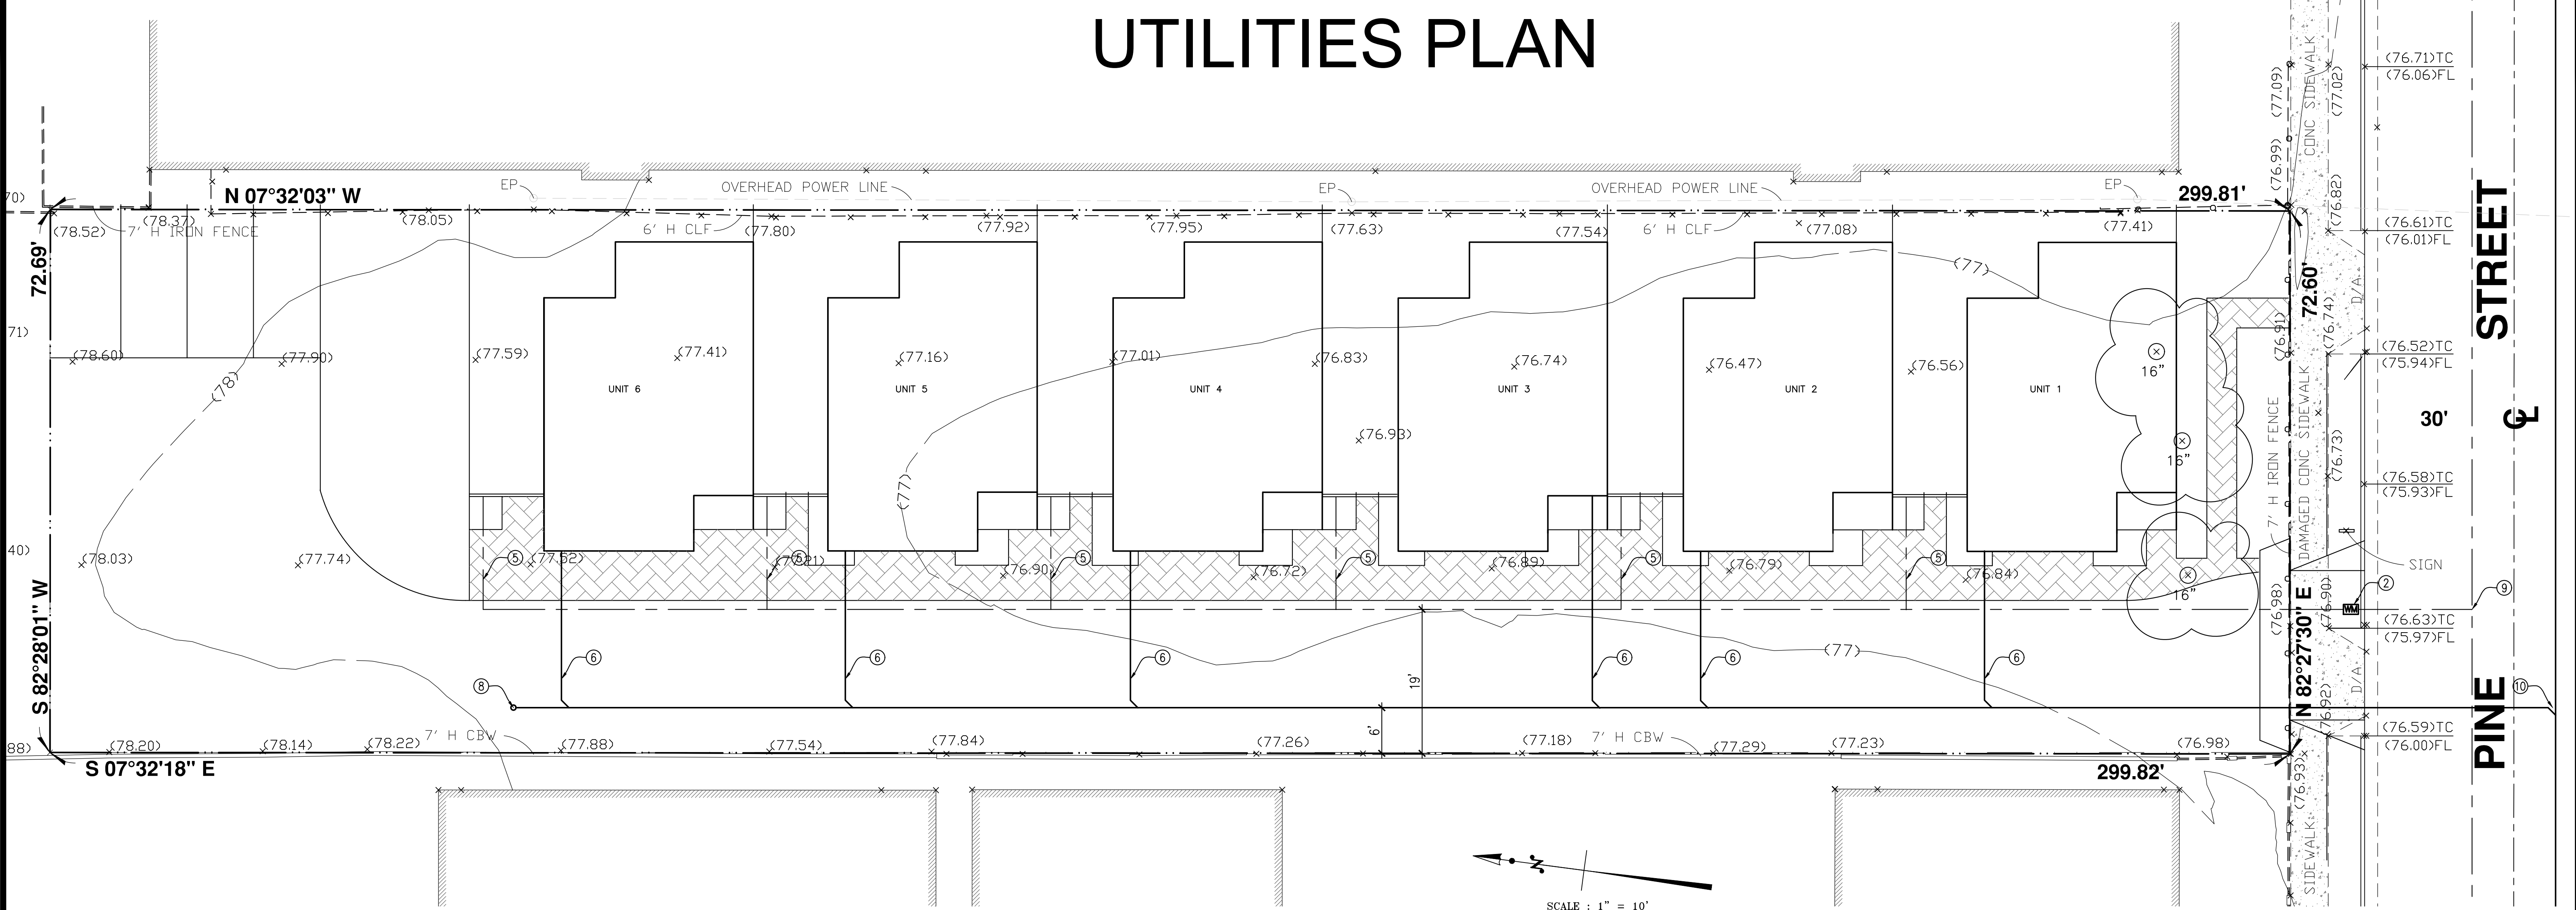

CONSTRUCTION NOTES:

- 1. CONST NEW 1-1/2" CW SERVICE
- 2. CONST NEW WATER METER WITH GATE VALVE IN CONC. VAULT TO REMAIN.
- 3. CONST NEW GATE VALVE IN Y.B. (PER PLUMBING PLAN)
- 4. CONST NEW 1-1/2" CW CAP-OFF
- 5. CONST NEW WATER SERVICE LINE TO BUILDING (PER PLUMBING PLAN)
- 6. CONST NEW 4" SEWER LATERAL
- 7. CONST NEW 4" PVC SEWER LATERAL (PER PLUMBING PLAN)
- 8. CONST. NEW CLEAN OUT CONTRACTOR VERIFY LOCATION BEFORE CONNECTING OF WORK
- 9. CONNECT (HOT TAP) TO EXISTING WATER MAIN
- 10. CONNECT TO EXISTING SEWER

ABBREVIATIONS:

C/B Catch Basin
CBW Conc. Block Wall
CLF Chain Linked Fence
CONC. Concrete
D/A Driveway Apron
EP Edison Pole
EX Existing
FF Finish Floor Elevation
FL Flow Line Elevation
GM Gas Meter
GV Gas Valve
RW Retaining Wall
SMH Sewer Manhole
TC Top of Curb Elevation
WM Water Meter
WV Water Valve

LEGEND:

(100.10) Existing Elevation
----- Wrought Iron Fence
⊕ Fire Hydrant
⌘ Street Light



2. WATER QUALITY OUTLET RESER

SOIL ENGINEER GSS ENGINEERING, INC. 11823 SLAUSON AVENUE, STE 46 SANTA FE SPRINGS, CA 90670 _____ Name	OWNER/CLIENT: MEI-LIN CHEN 18482 AGUIRO STREET, ROWLAND HEIGHTS, CA 91748	LEGAL DESCRIPTION LOT 12 OF BLK 12 OF BELLE-VERNON ACRES, IN THE CITY OF COMPTON, COUNTY OF LOS ANGELES, STATE OF CALIFORNIA, AS PER MAP RECORDED IN BOOK 9 PAGE 196 OF MAPS, IN THE OFFICE OF THE COUNTY RECORDER OF SAID COUNTY.	BENCH MARK B.M. NUMBER: PY6977 ELEV. 75.795 QUAD (YEAR) 2005 DESCRIPTION: CS MON IN C.B. 300MM(1FT) E/O CF 1M(3.3FT) N/O BCR @ NE COR ALAMEDA ST (E BBL) & EUCLID AVE MKD (BM 5-19A 1964)	CITY OF COMPTON APPROVED BY: _____ CITY ENGINEER DATE	PLANS PREPARED BY:  Bill Shen 4-8-2019 Date TRANS AMERICAN ENGINEERING 5341 LA MADERA AVE. El Monte, CA 91732 TEL: (626)258-9330	UTILITIES PLAN SCALE: 1"=10' APN: 6176-003-031 DATE: 4-11-2019 809 EAST PINE STREET COMPTON, CA 90221 SHEET No. C-6
--	--	---	--	---	--	--